


DETAIL F-1

DETAIL F-2

FLOOR DATA: PROVIDE "PER UNIT"
 2. SUPPLY
 3. BREAK: DEPENDS, TO BE RUN 5 FT. CIRCUM
 1. HUNG DATA: "PER UNIT"
 3. SPOCS: BRUSH CONDENSES
 24" x 24" BRASS
 15 KN SHEET PILE
 LABEL: LIVING 14 700 2ND 350
 POOR 146
 STORAGE 146
 TOTAL XZ = 2144

MINIMUM: 2000 4 1/2 FT
 FRONT ELEVATION

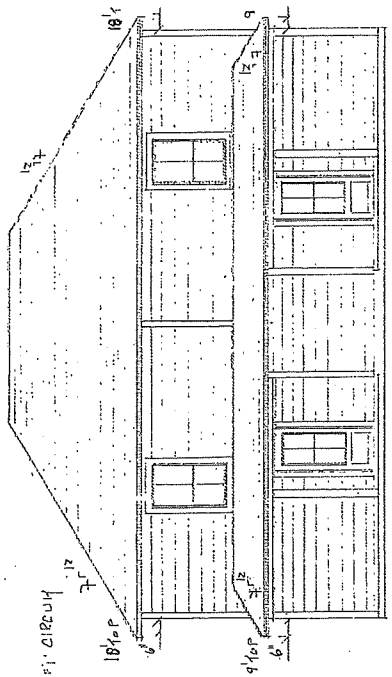


FRONT ELEVATION

- PLUMBING NOTES:
1. DUCT DIMENSIONS: INDICATED. CLEAR AREA NO. 60/10/10
 2. FOR INS.
 3. 2. 1/2\"/>
 - 4. INSULATION TO BE 2\"/>
 - 5. FLOOR TO BE 15\"/>
 - 6. 20\"/>
 - 7. WORK TO 1/2\"/>


- PLUMBING NOTES:
1. LOCATE SEWER IN THE DEFECT ROOM IN 2\"/>
 - 2. 1/2\"/>
 - 3. 1/2\"/>
 - 4. 1/2\"/>
 - 5. 1/2\"/>
 - 6. 1/2\"/>
 - 7. 1/2\"/>
 - 8. 1/2\"/>

PROPOSED RESIDENTIAL
 SCALE AS NOTED
 DATE 10-15-11
 SHEET 1002
 DRAWING NUMBER
 2144

MOSE FLOORS DESIGN, LLC
 1000 SPRING LA, 70725
 PHONE 504-884-8844

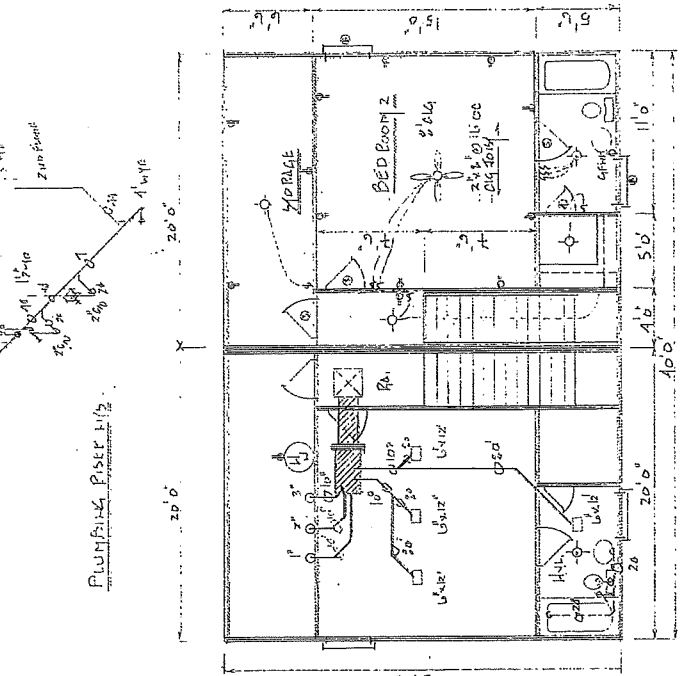

PLUMBING PLAN 1/2

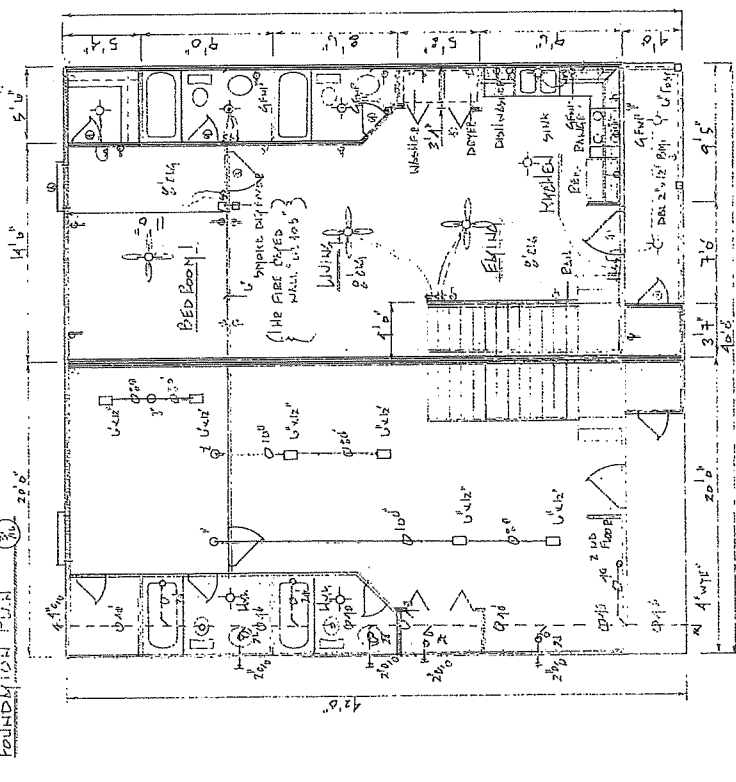

FLOOR PLAN

1/2 FLOOR PLAN PLUMBING

1/2

