


# ENDO

4211 MAINE TRAIL  
CRYSTAL LAKE, IL 60012  
Tel. 312.243.0222  
fax. 312.243.0698


ST. DESIGNER: JAC  
PROJECT NO.: 200196.80  
DATE: 02/22/02  
REVISION: 1.00  
JOB NO.: 200196.80  
ELECTRICAL: J. BRADY, J. AN

PROJECT NAME: *Krupp & Krich*  
**CLIX**  
WILLIAMS STREET STUDIO  
CRYSTAL LAKE, IL  
SHEET NO.:  
**POWER PLAN**

PROJECT NO.: 200196.80  
SHEET NO.: **E2**

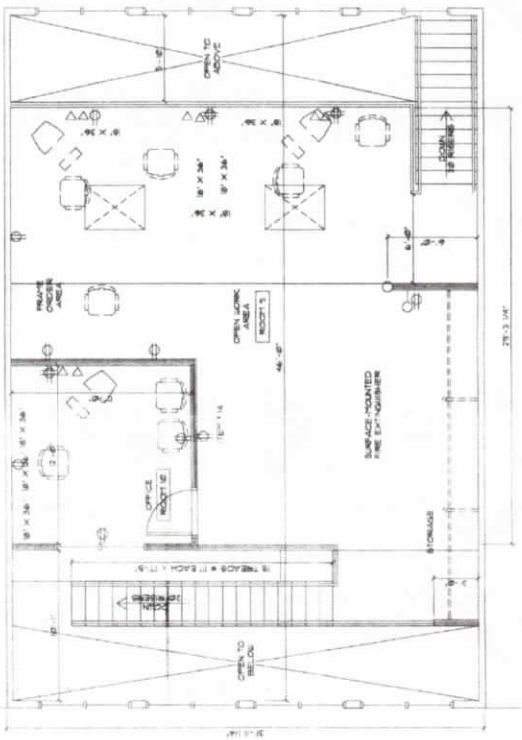

**MEZZANINE ELECTRICAL**

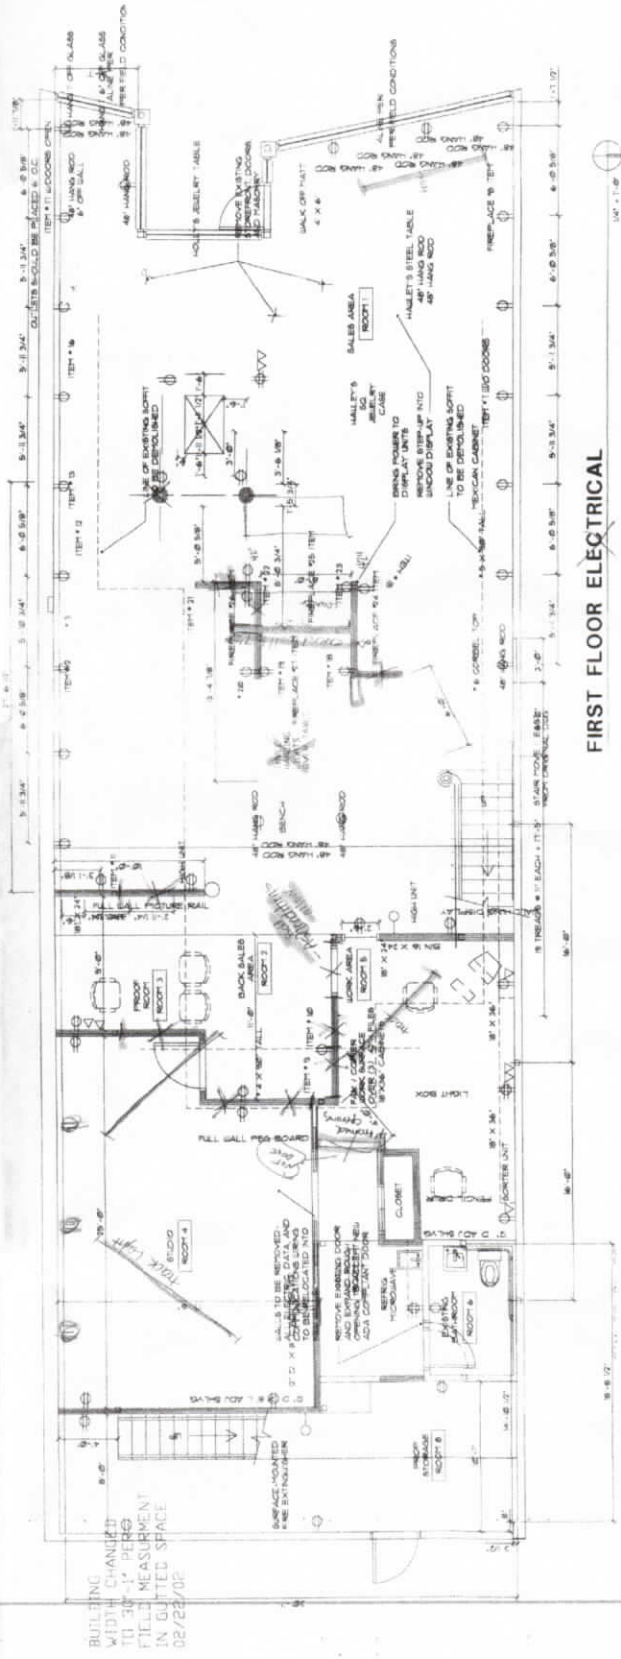

**FIRST FLOOR ELECTRICAL**

BUILDING CHANGED  
WIDTH CHANGED  
TO 30'-1\"/>

FIELD MEASUREMENT  
IN QUOTED SPACE  
02/22/02