


NEW FLOOR PLAN

SCALE: 1/4"=1'-0"

MANALAPAN ORACLE CAPITAL MANAGEMENT, LLC


BUILDING "A" SUITE 202 620 TINTON AVE. TINTON FALLS, NJ

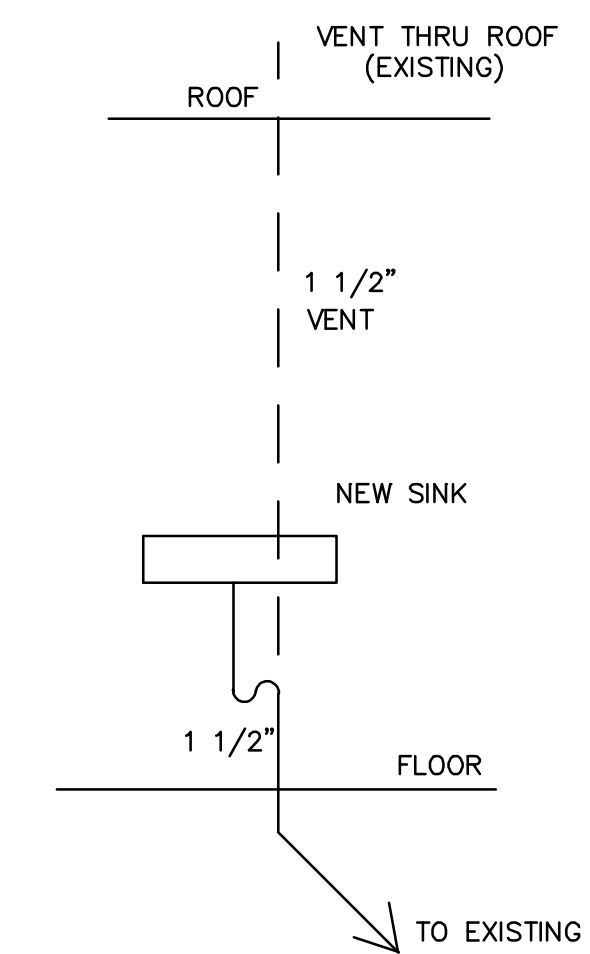

PLUMBING RISER DIAGRAM
NO SCALE

— EXISTING WALLS TO REMAIN
 - - - NEW WALLS

BLOCK NO. 76.01
 LOT NO. 2

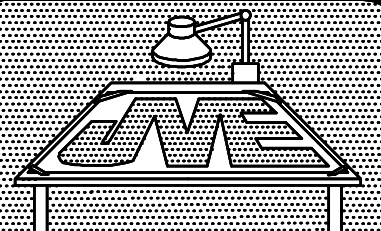	
CHECKED BY	JVE
DRAWN BY	JVE
SCALE	1/4"=1'-0"
DATE	7/11/12
REVISIONS	7/23/12
DRAWING TITLE NEW FLOOR PLAN MANALAPAN ORACLE CAPITAL MANAGEMENT, LLC	
PROJECT TITLE SECOND FLOOR FIT-OUT TO 620 TINTON AVE. BUILDING "A" OWNER STAVOLA REALTY COMPANY	
120 MORRIS AVENUE SPRINGFIELD, N.J. 07081 PHONE: 973-232-6426 FAX: 973-232-6492	
JAMES V. ESPOSITO ARCHITECT	
LIC. NO. A100714	
JOB NO.	31
DWG. NO.	1