 
 
 
 
 
 
 



LIGHTING SCHEDULE	
SYMBOL	DESCRIPTION
	EXISTING 2x4 FLUORESCENT FIXTURE NOTE: 'R' INDICATES RELOCATED FIXTURE
	NEW 2x4 FLUORESCENT FIXTURE
	EXISTING RECESSED FIXTURE
	EXISTING EMERGENCY FIXTURE
	EXISTING FIRE HORN AND STROBE
	EXISTING SPRINKLER HEADS
	EXISTING SMOKE DETECTOR

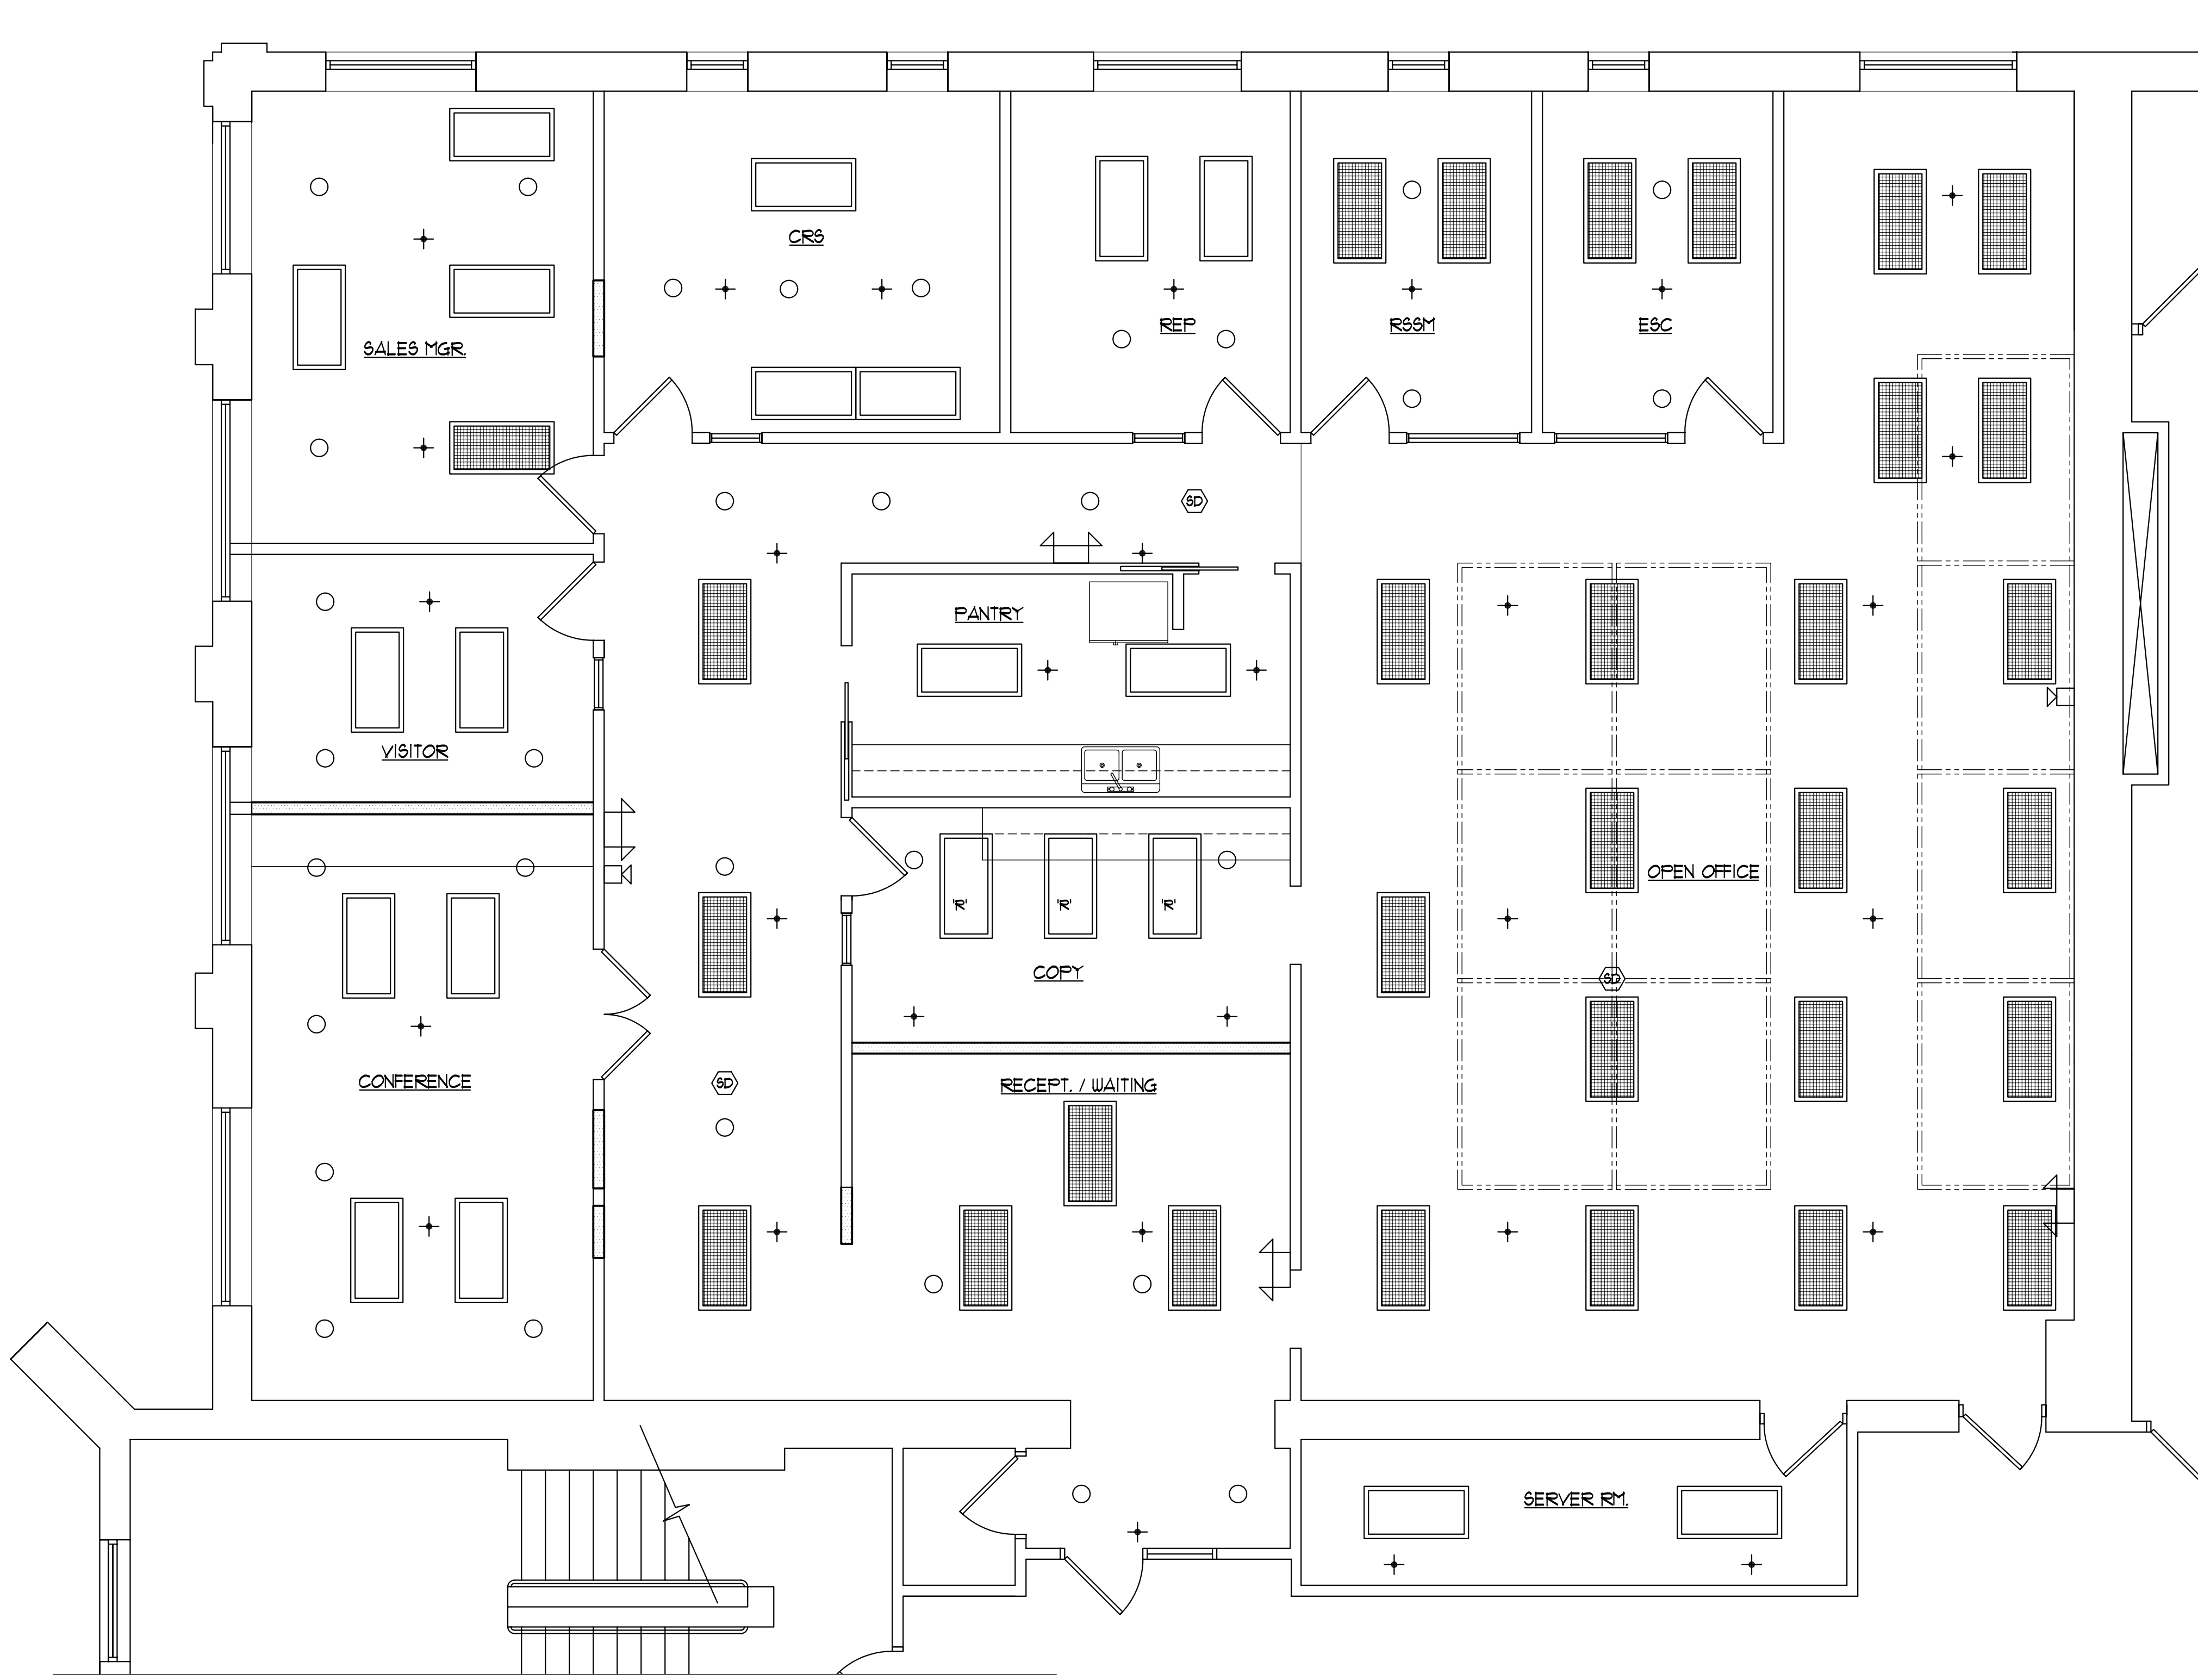

 PROPOSED REFLECTED CEILING PLAN
SCALE: 1/4"=1'-0"

COPYRIGHT © 2012
JON SARKESIAN ARCHITECTS, P.C.
ALL RIGHTS RESERVED

NOTE:
GREAT CARE AND EFFORT HAVE GONE INTO THE CREATION OF THESE CONSTRUCTION DOCUMENTS. HOWEVER, ERRORS AND OMISSIONS THAT MAY OCCUR SHOULD BE BROUGHT TO THE ATTENTION OF THE GENERAL CONTRACTOR IN WRITING. AND WRITTEN INSTRUCTION SHALL BE OBTAINED PRIOR TO PROCEEDING WITH CONSTRUCTION.

THE GENERAL CONTRACTOR MUST NOTIFY THE ARCHITECT OF ANY ISSUES THAT REQUIRE ADDITIONS TO OR REVISIONS OF THESE CONSTRUCTION DOCUMENTS.

THE SUBCONTRACTOR(S) ASSUME RESPONSIBILITY FOR ANY ERRORS OR OMISSIONS OF WHICH HE/SHE FAILED TO NOTIFY THE GENERAL CONTRACTOR PRIOR TO CONSTRUCTION.

JOB NO. _____
ISSUED FOR:
TENANT REVIEW 10-19-12
TENANT REVIEW 10-29-12

333 W. 11TH ST. SUITE #310
ROYAL OAK, MICHIGAN 48067
JON SARKESIAN ARCHITECTS, P.C.
ROYAL OAK, MI 48067
TEL: 248.398.4100
FAX: 248.398.0330
WWW.JSA-ARCH.COM

SHEET NO.
A-2