



FLOOR PLAN - SYSTEMS - DEMO & NEW WORK
SCALE: 1/8" = 1'-0"

GENERAL NOTES:

1. ALL EXISTING ABANDONED LOW VOLTAGE NETWORK CABLE TO BE REMOVED BACK TO SOURCE BY OWNER'S LOW VOLTAGE CONTRACTOR.
2. ELECTRICAL CONTRACTOR TO PROVIDE BLANK COVER PLATES ON ALL ABANDONED ROUGHINS. PLATES TO MATCH COLOR OF RECEPTACLE PLATES. CONFIRM ALL COLOR SELECTIONS WITH THE OWNER.

DEMOLITION NOTES - (FOR THIS SHEET ONLY) (○) SYMBOL


1. REMOVE STATION OUTLET AND CABLE BACK TO SOURCE. PROVIDE BLANK COVER PLATE.
2. REMOVE STATION OUTLET AND CABLE BACK TO SOURCE. OWNER'S VENDOR WILL INSTALL NEW STATION OUTLET, STATION CABLE AND ALL WORK TO ESTABLISH NEW VOIP NETWORK.
3. REMOVE ALL SURFACE RACEWAY, POWER POLES, LOW VOLTAGE CABLE/STATION OUTLETS ASSOCIATED WITH LAB CASEWORK BACK TO SOURCE.

NEW WORK NOTES - (FOR THIS SHEET ONLY) (○) SYMBOL

1. PROVIDE NEW 2 GANG WIREMOLD BOX AND WIREMOLD TO ABOVE CEILING FOR STATION OUTLET AND CABLE BY OWNERS VENDOR.
2. PROVIDE NEW 2 GANG WIREMOLD BOX AND WIREMOLD TO ABOVE CEILING. WHIP IN TO OFFICE PARTITION BASE BOARD RACEWAY.
3. CUT AND PATCH WALL TO INSTALL ROUGHIN AND CONDUIT STUB. STATION OUTLET AND CABLE BY OWNERS VENDOR.
4. POWER POLE FURNISHED BY OFFICE FURNITURE VENDOR.
5. STATION OUTLET AND CABLE IN FURNITURE BASE RAIL.
6. CUT AND PATCH WALL FOR NEW ROUGHIN AND CONDUIT STUB. WHIP TO OFFICE FURNITURE BASE RAIL.
7. SURFACE RACEWAY AND ROUGHIN UP 60" FOR MONITOR.

Date	No.	Revision

Project No. 3000.883	Approved JWA
Designed JWA	Checked JWA
Drawn RCN	Approved JWA

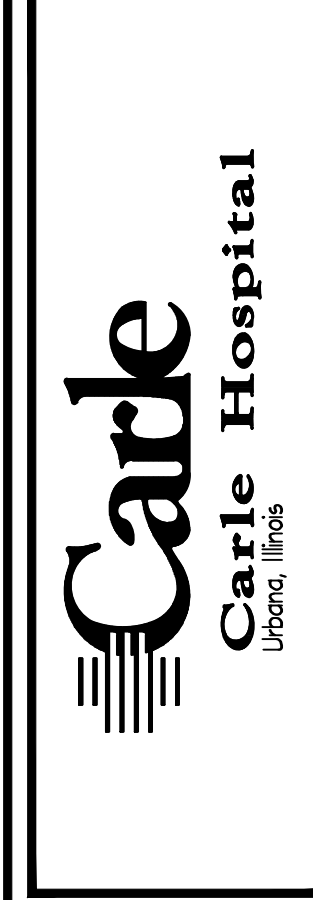

Sheet Title: **FLOOR PLAN - SYSTEMS - DEMO & NEW WORK**
NEW HEALTH ALLIANCE OFFICE REMODEL
201 DEVONSHIRE, CHAMPAIGN ILLINOIS

GHR Engineers and Associates, Inc.
Mechanical & Electrical Consulting Engineers
1615 South Neil Street
Champaign, Illinois 61820
Tel: (217) 356-0536 Fax: (217) 356-1092

Date: AUG 22, 2014

Sheet: **E3**
of 3